



# DEA Water Tech

WEFTEC 2023  
DWT-WEF-23-10

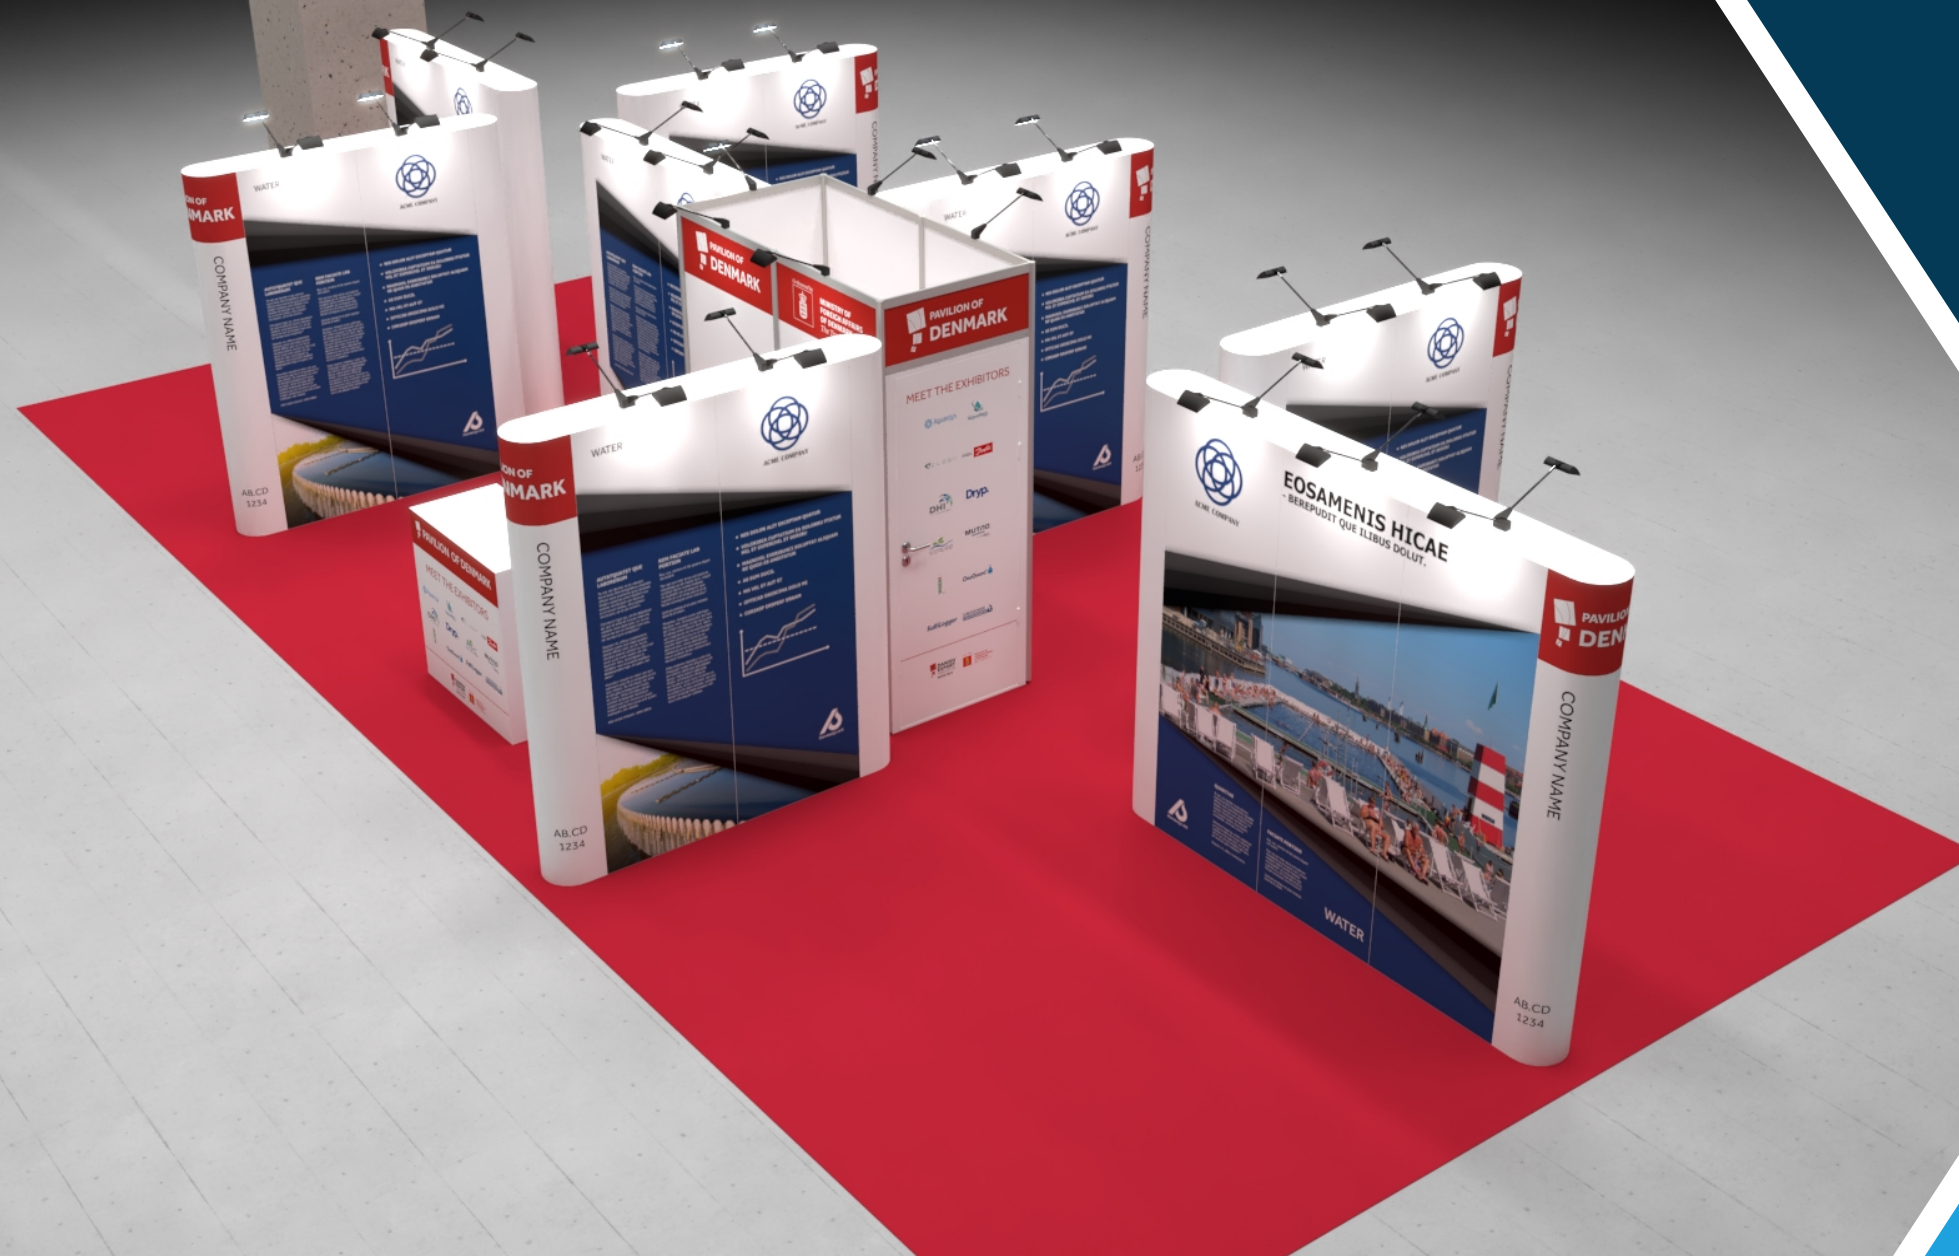


✓ RÅDGIVNING ✓ DESIGN ✓ HÅNDVÆRK ✓ TEKNOLOGI



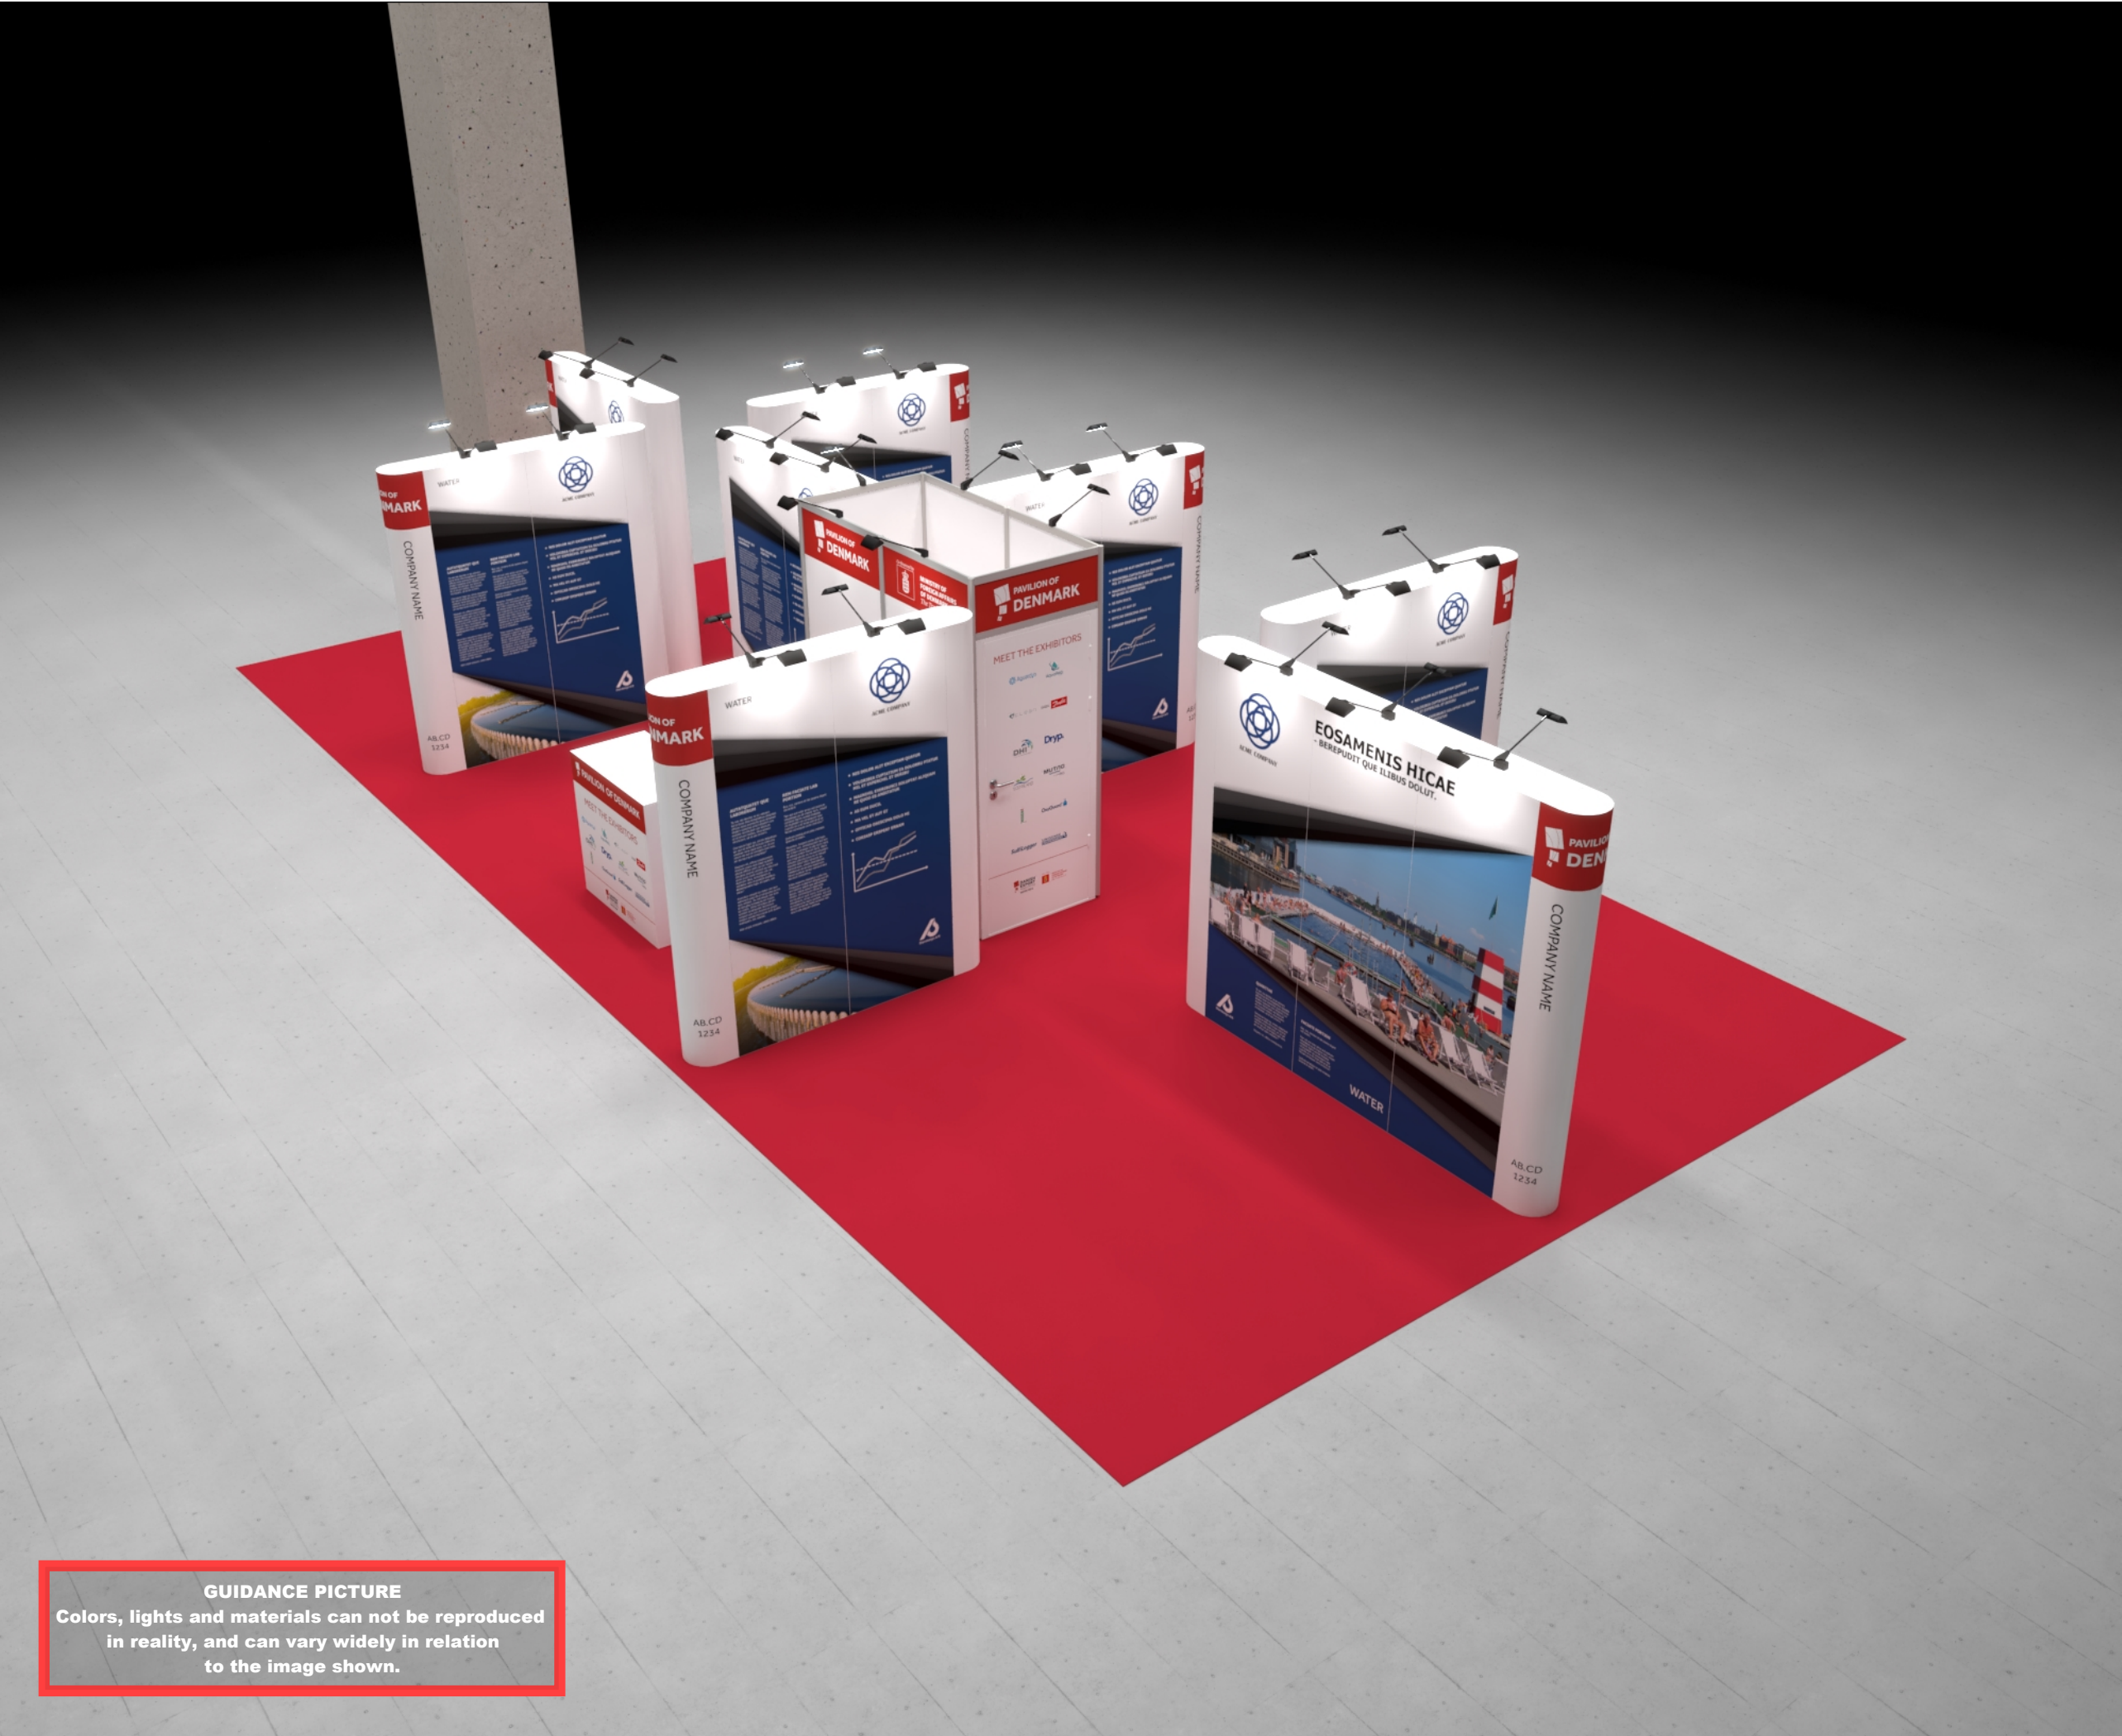

**GUIDANCE PICTURE**  
Colors, lights and materials can not be reproduced  
in reality, and can vary widely in relation  
to the image shown.




Standesign A/S  
Alsvej 2F  
5800 Nyborg  
Denmark  
Phone: +45 4484 6699

Project no.: DWT-WEF-23-10  
Drawing no.: 3D-001  
Drawing title: Bird View 1  
Designed by: THJ  
Hall: North Building  
Booth: 8327


Creation date: 30-05-2023  
Revision date: 29-06-2023  
Revision no.: F

Client: DEA Water Tech



DANISH  
EXPORT  
ASSOCIATION  
WATER TECH

Exhibition: WEFTEC 2023  
McCormick Place, Chicago, IL




weftec  
the water quality event™

Comments:

The drawing is indicative and without responsibility. The drawing is NOT to scale. The stand-builder will have the final call in all decisions regarding stability and security. Some products are only shown to indicate locations, but not the actual product as this product may be changed. All design is subject to copyright by Standesign A/S








Standesign A/S  
Alsvej 2F  
5800 Nyborg  
Denmark  
Phone: +45 4484 6699

Project no.: DWT-WEF-23-10  
Drawing no.: 3D-002  
Drawing title: Street View 1  
Designed by: THJ  
Hall: North Building  
Booth: 8327


Creation date: 30-05-2023  
Revision date: 29-06-2023  
Revision no.: F

Client: DEA Water Tech



DANISH  
EXPORT  
ASSOCIATION  
WATER TECH

Exhibition: WEFTEC 2023  
McCormick Place, Chicago, IL



weftec  
the water quality event™




Comments:

The drawing is indicative and without responsibility. The drawing is NOT to scale. The stand-builder will have the final call in all decisions regarding stability and security. Some products are only shown to indicate locations, but not the actual product as this product may be changed. All design is subject to copyright by Standesign A/S

**GUIDANCE PICTURE**  
Colors, lights and materials can not be reproduced in reality, and can vary widely in relation to the image shown.





<div><div><div>Standesign A/S Alsvej 2F 5800 Nyborg Denmark Phone: +45 4484 6699</div></div></div>	
Project no.:	DWT-WEF-23-10
Drawing no.:	3D-003
Drawing title:	Street View 2
Designed by:	THJ
Hall:	North Building
Booth:	8327
Creation date:	30-05-2023
Revision date:	29-06-2023
Revision no.:	F
Client: DEA Water Tech	
<div><div><div>DANISH EXPORT ASSOCIATION WATER TECH</div></div></div>	
Exhibition: WEFTEC 2023 McCormick Place, Chicago, IL	
	
Comments:	
<div>The drawing is indicative and without responsibility. The drawing is NOT to scale. The stand-builder will have the final call in all decisions regarding stability and security. Some products are only shown to indicate locations, but not the actual product as this product may be changed. All design is subject to copyright by Standesign A/S</div>	

**GUIDANCE PICTURE**  
Colors, lights and materials can not be reproduced in reality, and can vary widely in relation to the image shown.

8529

8527

Project no.: DWT-WEF-23-10  
Drawing no.: FP-001  
Drawing title: Floor Plan  
Designed by: THJ  
Hall: North Building  
Booth: 8327

Creation date: 30-05-2023  
Revision date: 29-06-2023  
Revision no.: F

Client: DEA Water Tech




Exhibition: WEFTEC 2023  
McCormick Place, Chicago, IL



Comments:  
■ - Pillar/Column  
- (P) Poster stand

The drawing is indicative and without responsibility. The drawing is NOT to scale.  
The stand-builder will have the final call in all decisions regarding stability and security.  
Some products are only shown to indicate locations, but not the actual product as this product may be changed.  
All design is subject to copyright by Standesign A/S

**Booth: 8327**  
**Hall: North Building**

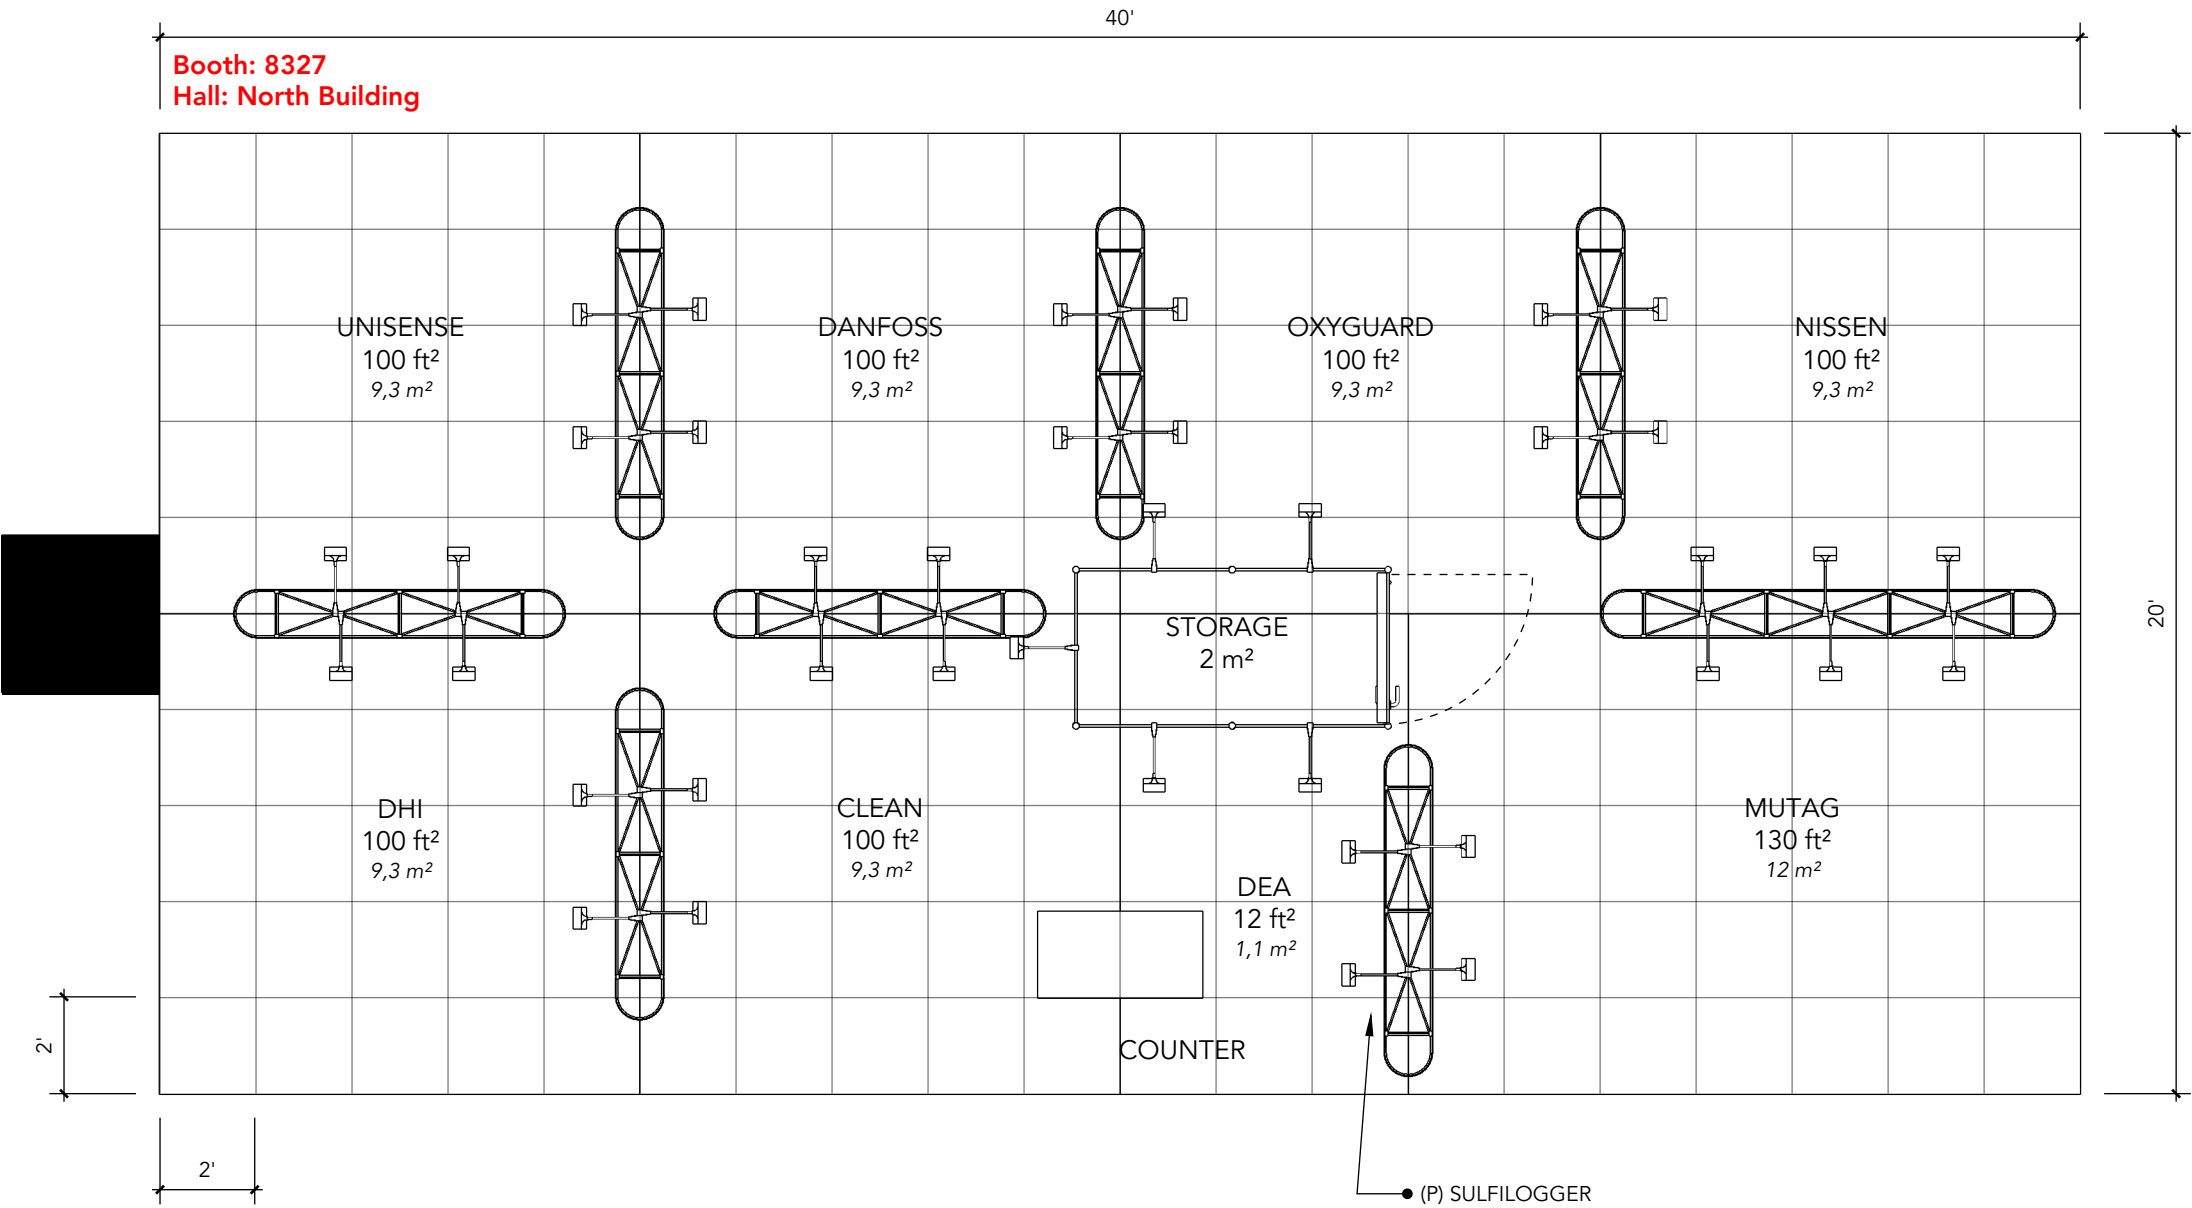


8229

8228

8227



ELEVATION FRONT

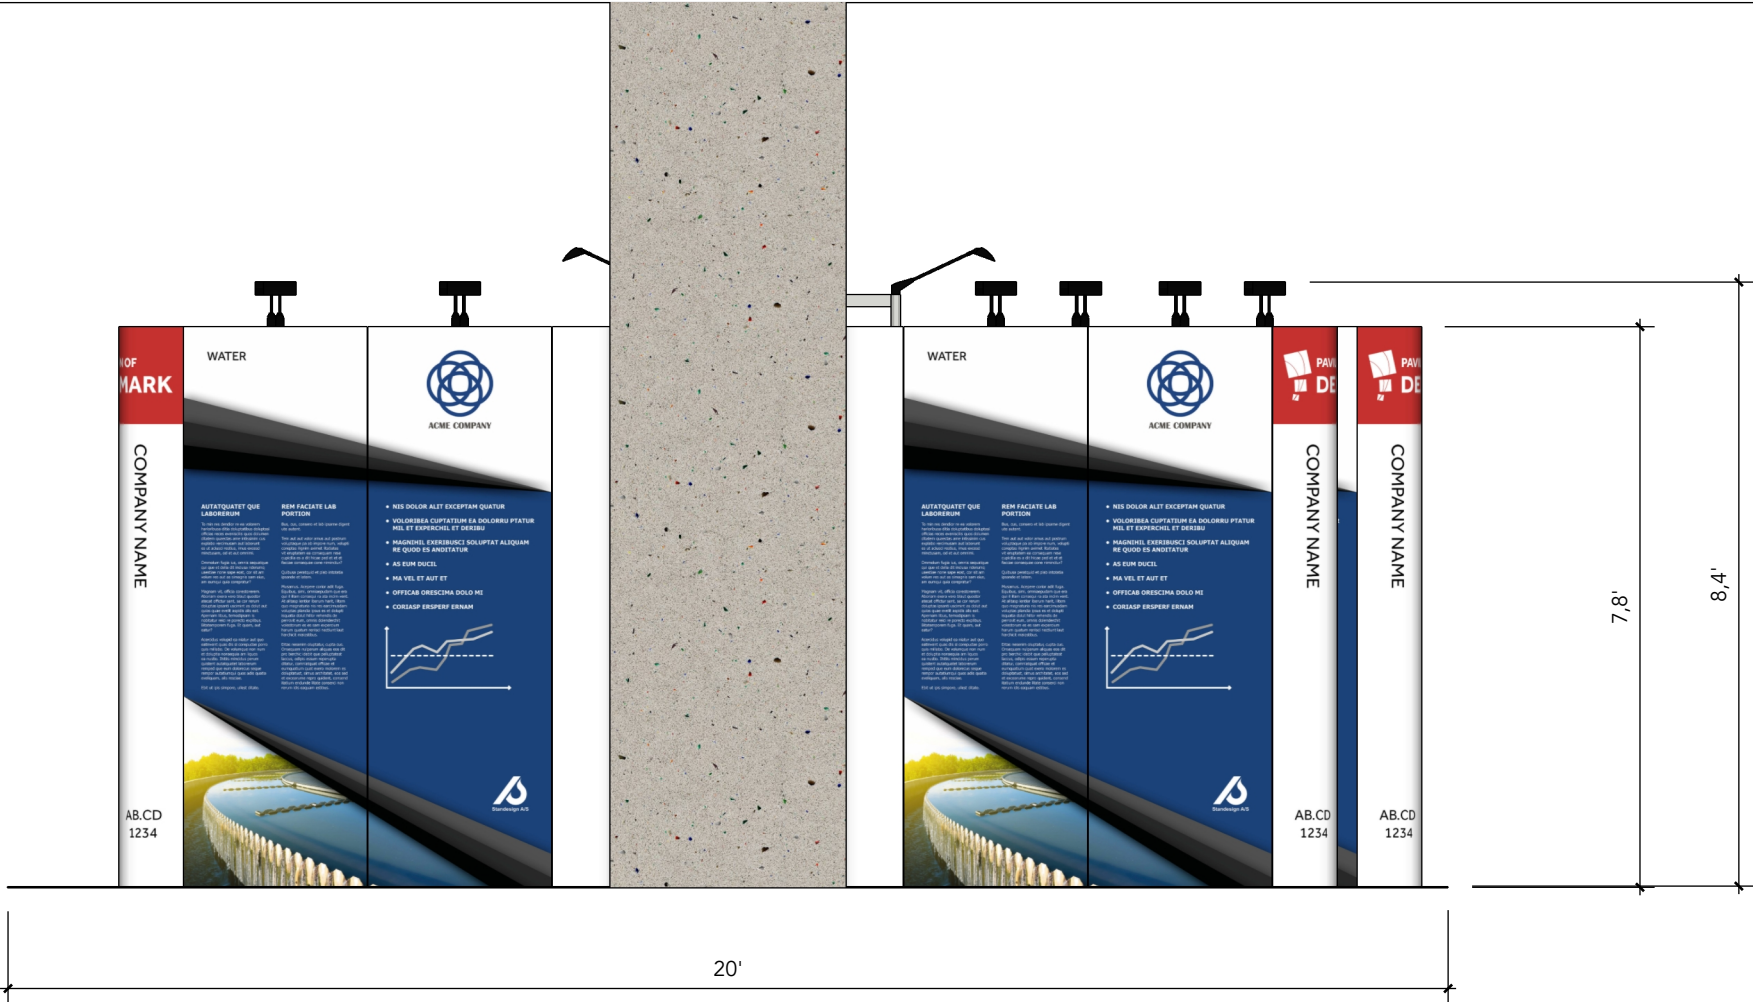

**Standesign A/S**  
Alsvej 2F  
5800 Nyborg  
Denmark  
Phone: +45 4484 6699

Project no.: DWT-WEF-23-10  
Drawing no.: EV-001  
Drawing title: Elevations  
Designed by: THJ  
Hall: North Building  
Booth: 8327  
  
Creation date: 30-05-2023  
Revision date: 29-06-2023  
Revision no.: F

Client: DEA Water Tech


**DANISH EXPORT ASSOCIATION**  
**WATER TECH**

Exhibition: WEFTEC 2023  
McCormick Place, Chicago, IL

**weftec**  
the water quality event™

Comments:

ELEVATION SIDE

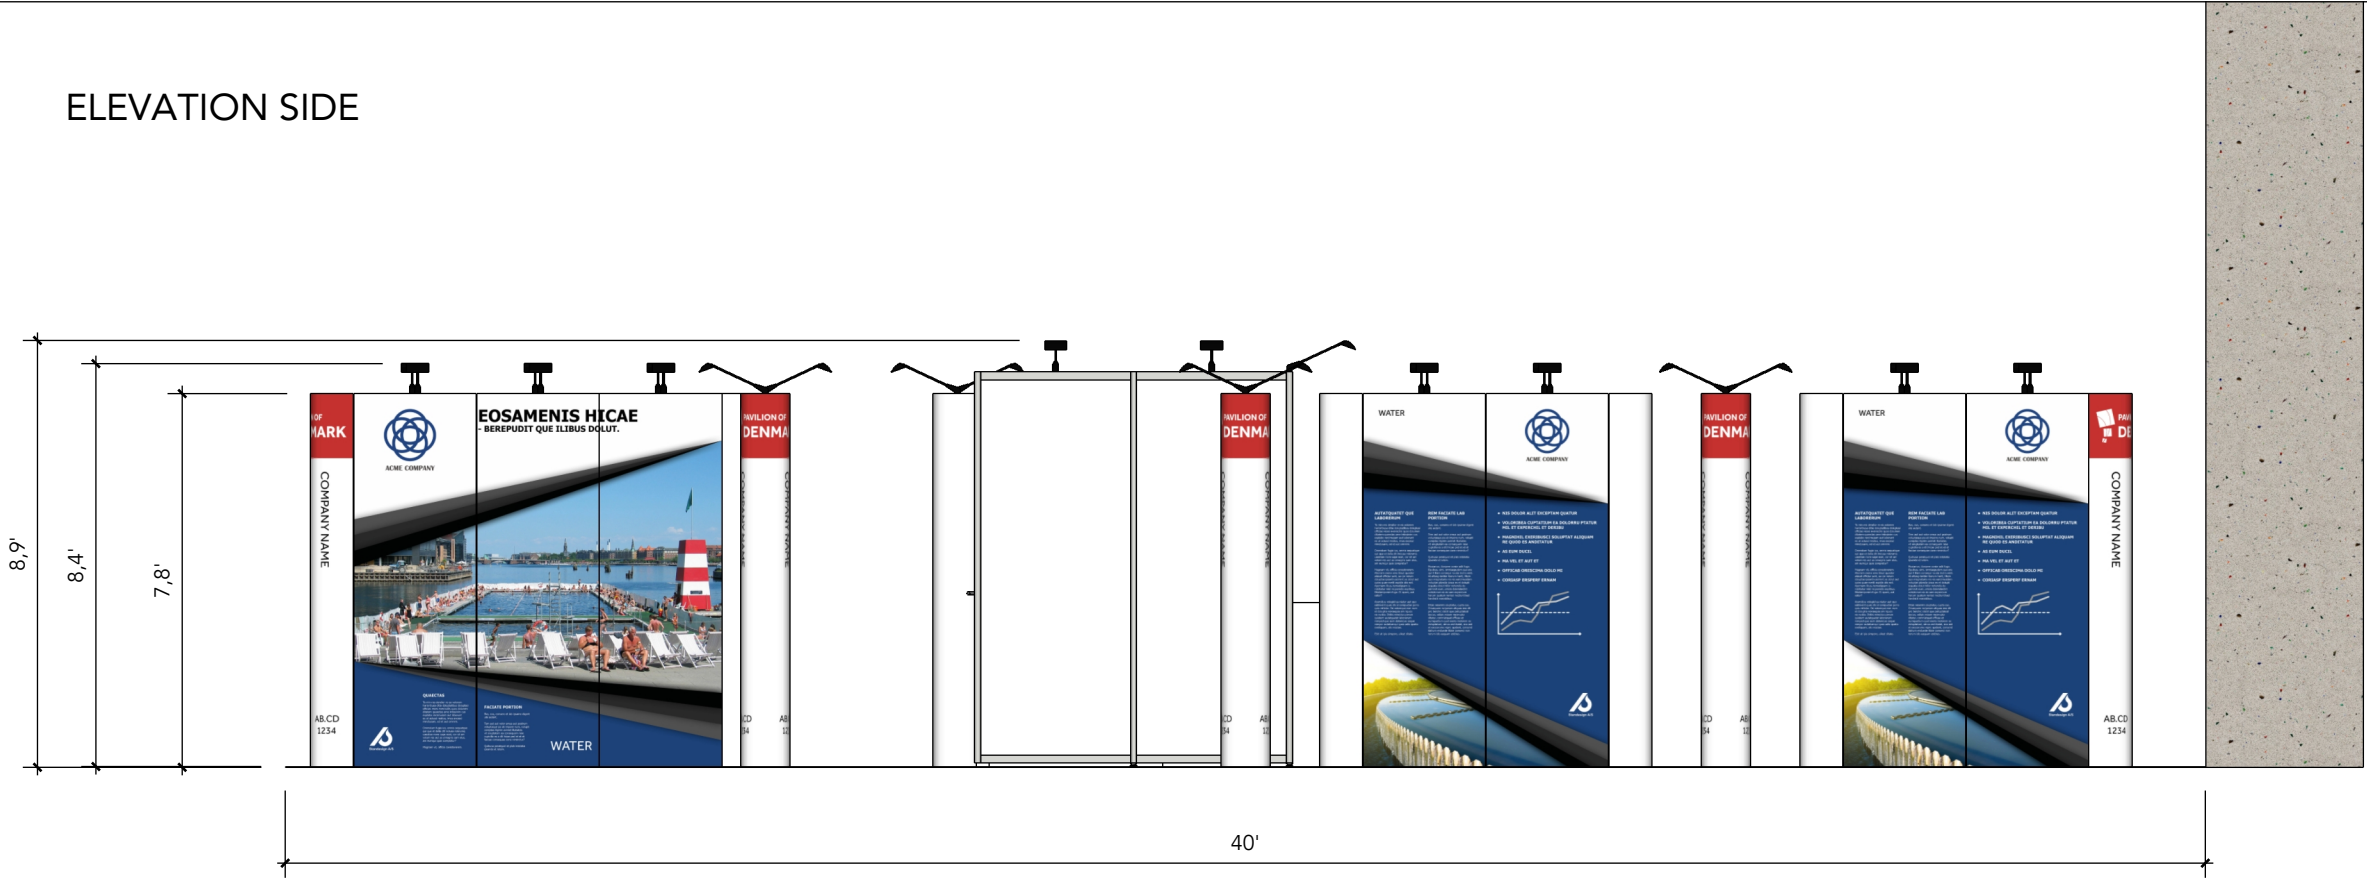

The drawing is indicative and without responsibility. The drawing is NOT to scale. The stand-builder will have the final call in all decisions regarding stability and security. Some products are only shown to indicate locations, but not the actual product as this product may be changed. All design is subject to copyright by Standesign A/S